 
 
 





 
 
 





GENERAL NOTES

- | SYMBOL | DESCRIPTION |
|---|--|
|  | SHEET METAL DUCT |
|  | EXISTING SHEET METAL DUCT |
|  | REMOVE EXISTING DUCT |
|  | FLEXIBLE DUCT |
|  | SUPPLY DIFFUSER - LETTER & NUMBER
INDICATES TYPE & CFM |
|  | RETURN GRILLE - LETTER & NUMBER
INDICATES TYPE & CFM |
|  | EXHAUST GRILLE - LETTER & NUMBER
INDICATES TYPE & CFM |
|  | SIDEWALL SUPPLY GRILLE - LETTER & NUMBER
INDICATES TYPE & CFM |
|  | SIDEWALL RETURN GRILLE - LETTER & NUMBER
INDICATES TYPE & CFM |
|  | EXISTING SUPPLY DIFFUSER |
|  | EXISTING RETURN GRILLE |
|  | EXISTING EXHAUST GRILLE |
|  | ELBOW WITH TURNING VANES |
|  | CONNECT TO EXISTING |



OUTSIDE AIR SUMMARY



GRILLE & DIFFUSER SCHEDULE							
MARK	BASIS OF DESIGN	SERVICE	TYPE	MAX. CFM	FACE SIZE	NECK SIZE	NOTES
EA	PRICE 530	EXHAUST	SURFACE MOUNT	150	12"X12"	6"	1-5

NOTES:

1. COORDINATE FINISH WITH ARCHITECT.
2. GRILLE TO HAVE FULLY LOUVERED FACE.
3. PROVIDE WITH INSULATED SHEET METAL FLENUM.
4. FRAME FOR SURFACE MOUNTING.
5. PROVIDE WITH OPPOSED BLADE DAMPER.

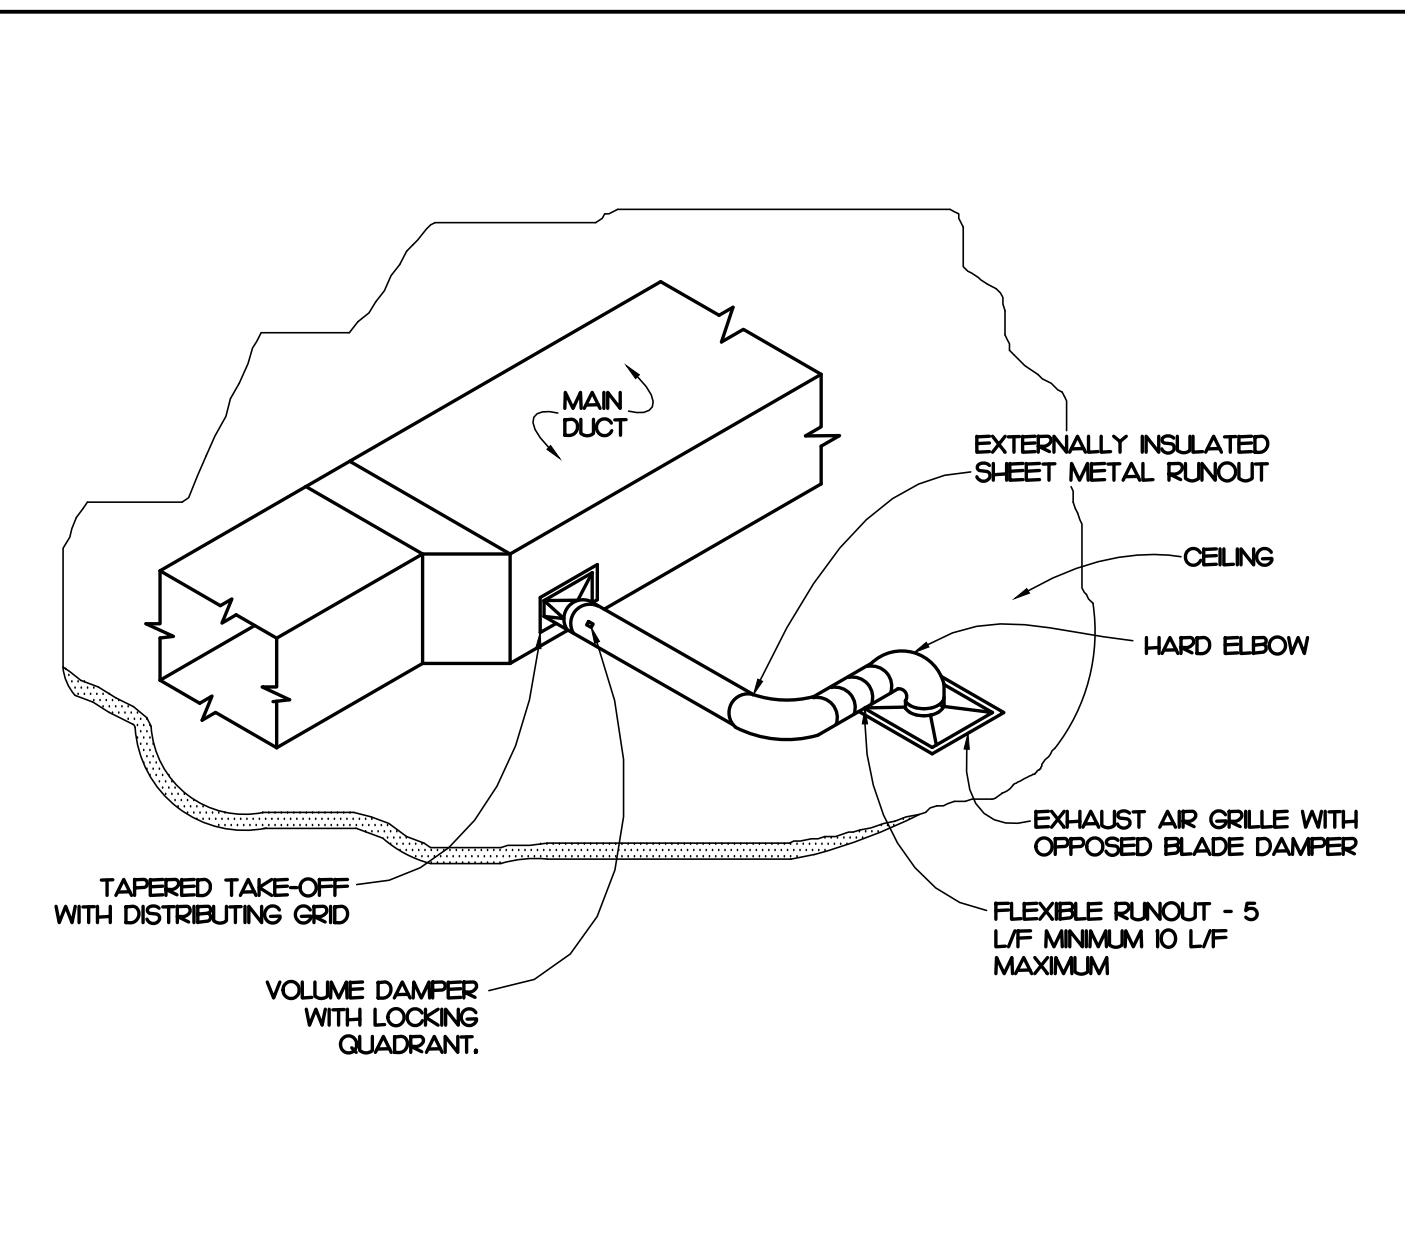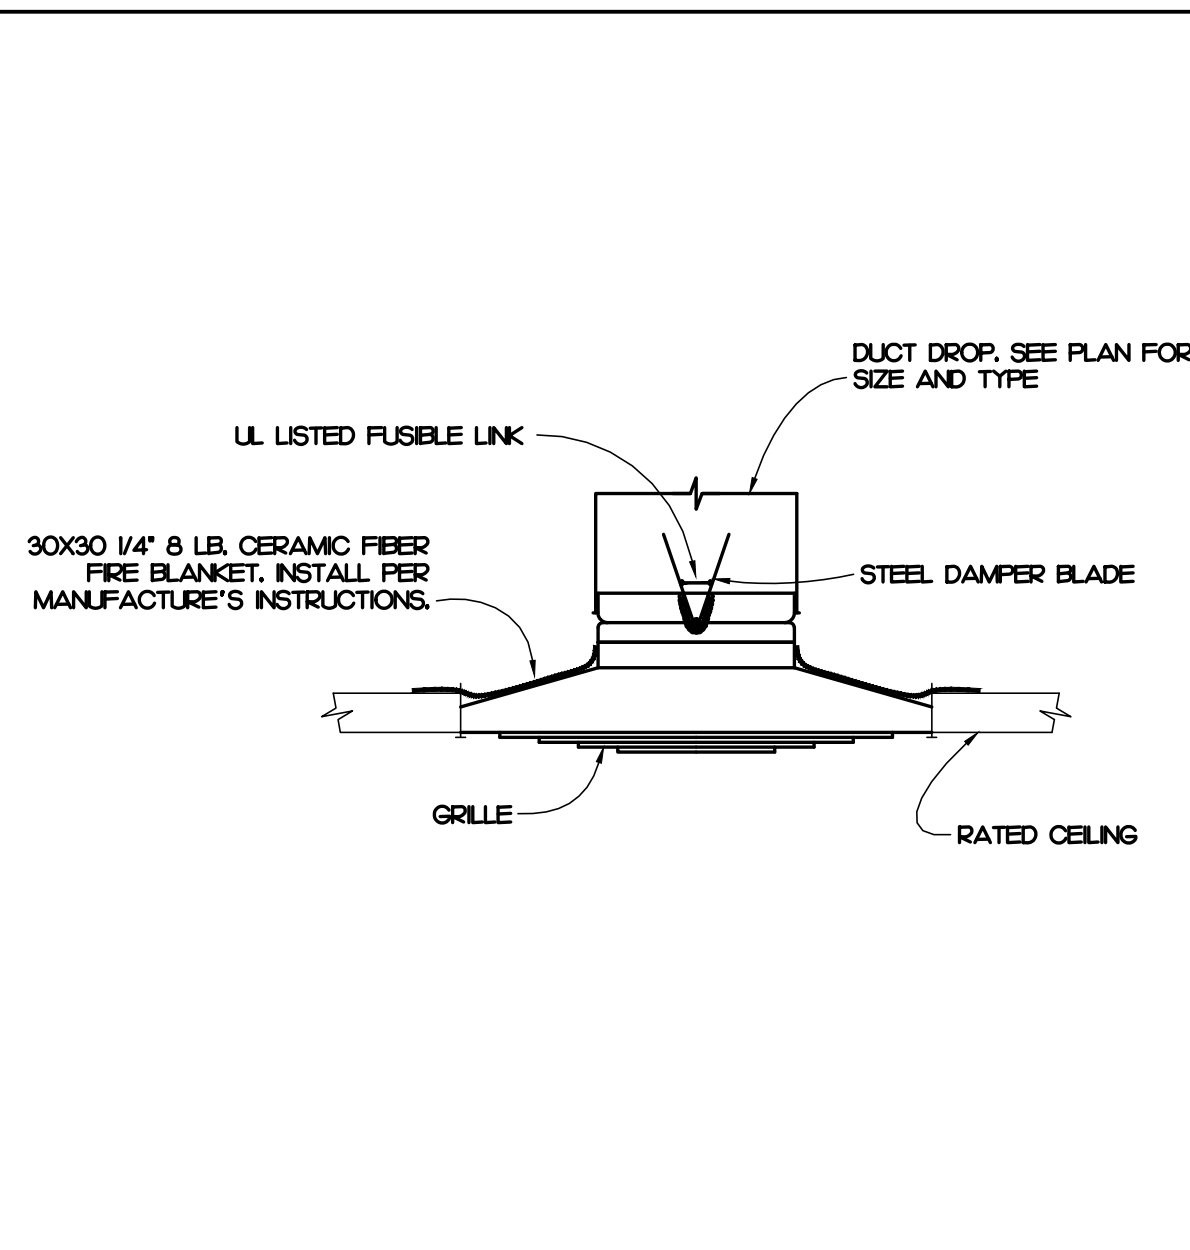

ATLANTEC
ENGINEERS, PA

IMEG
CONSULTANTS
CORP.
No. 1-1507

SEAL
025036
ENGINEER
BRADLEY W. FELLIS

5/24/16

302 BLUE RIDGE ROAD, SUITE 10
GREENSBORO, NC 27402
(866) 591-1144
24046

GOVERNOR MOREHEAD SCHOOL
SPRINKLER, ADA TOILET, LIGHTING
UPGRADES FOR DORMS A, B, + D
RALEIGH, NC

DATE: **May 27, 2025**

SHEET NO.

OF ...