


24048

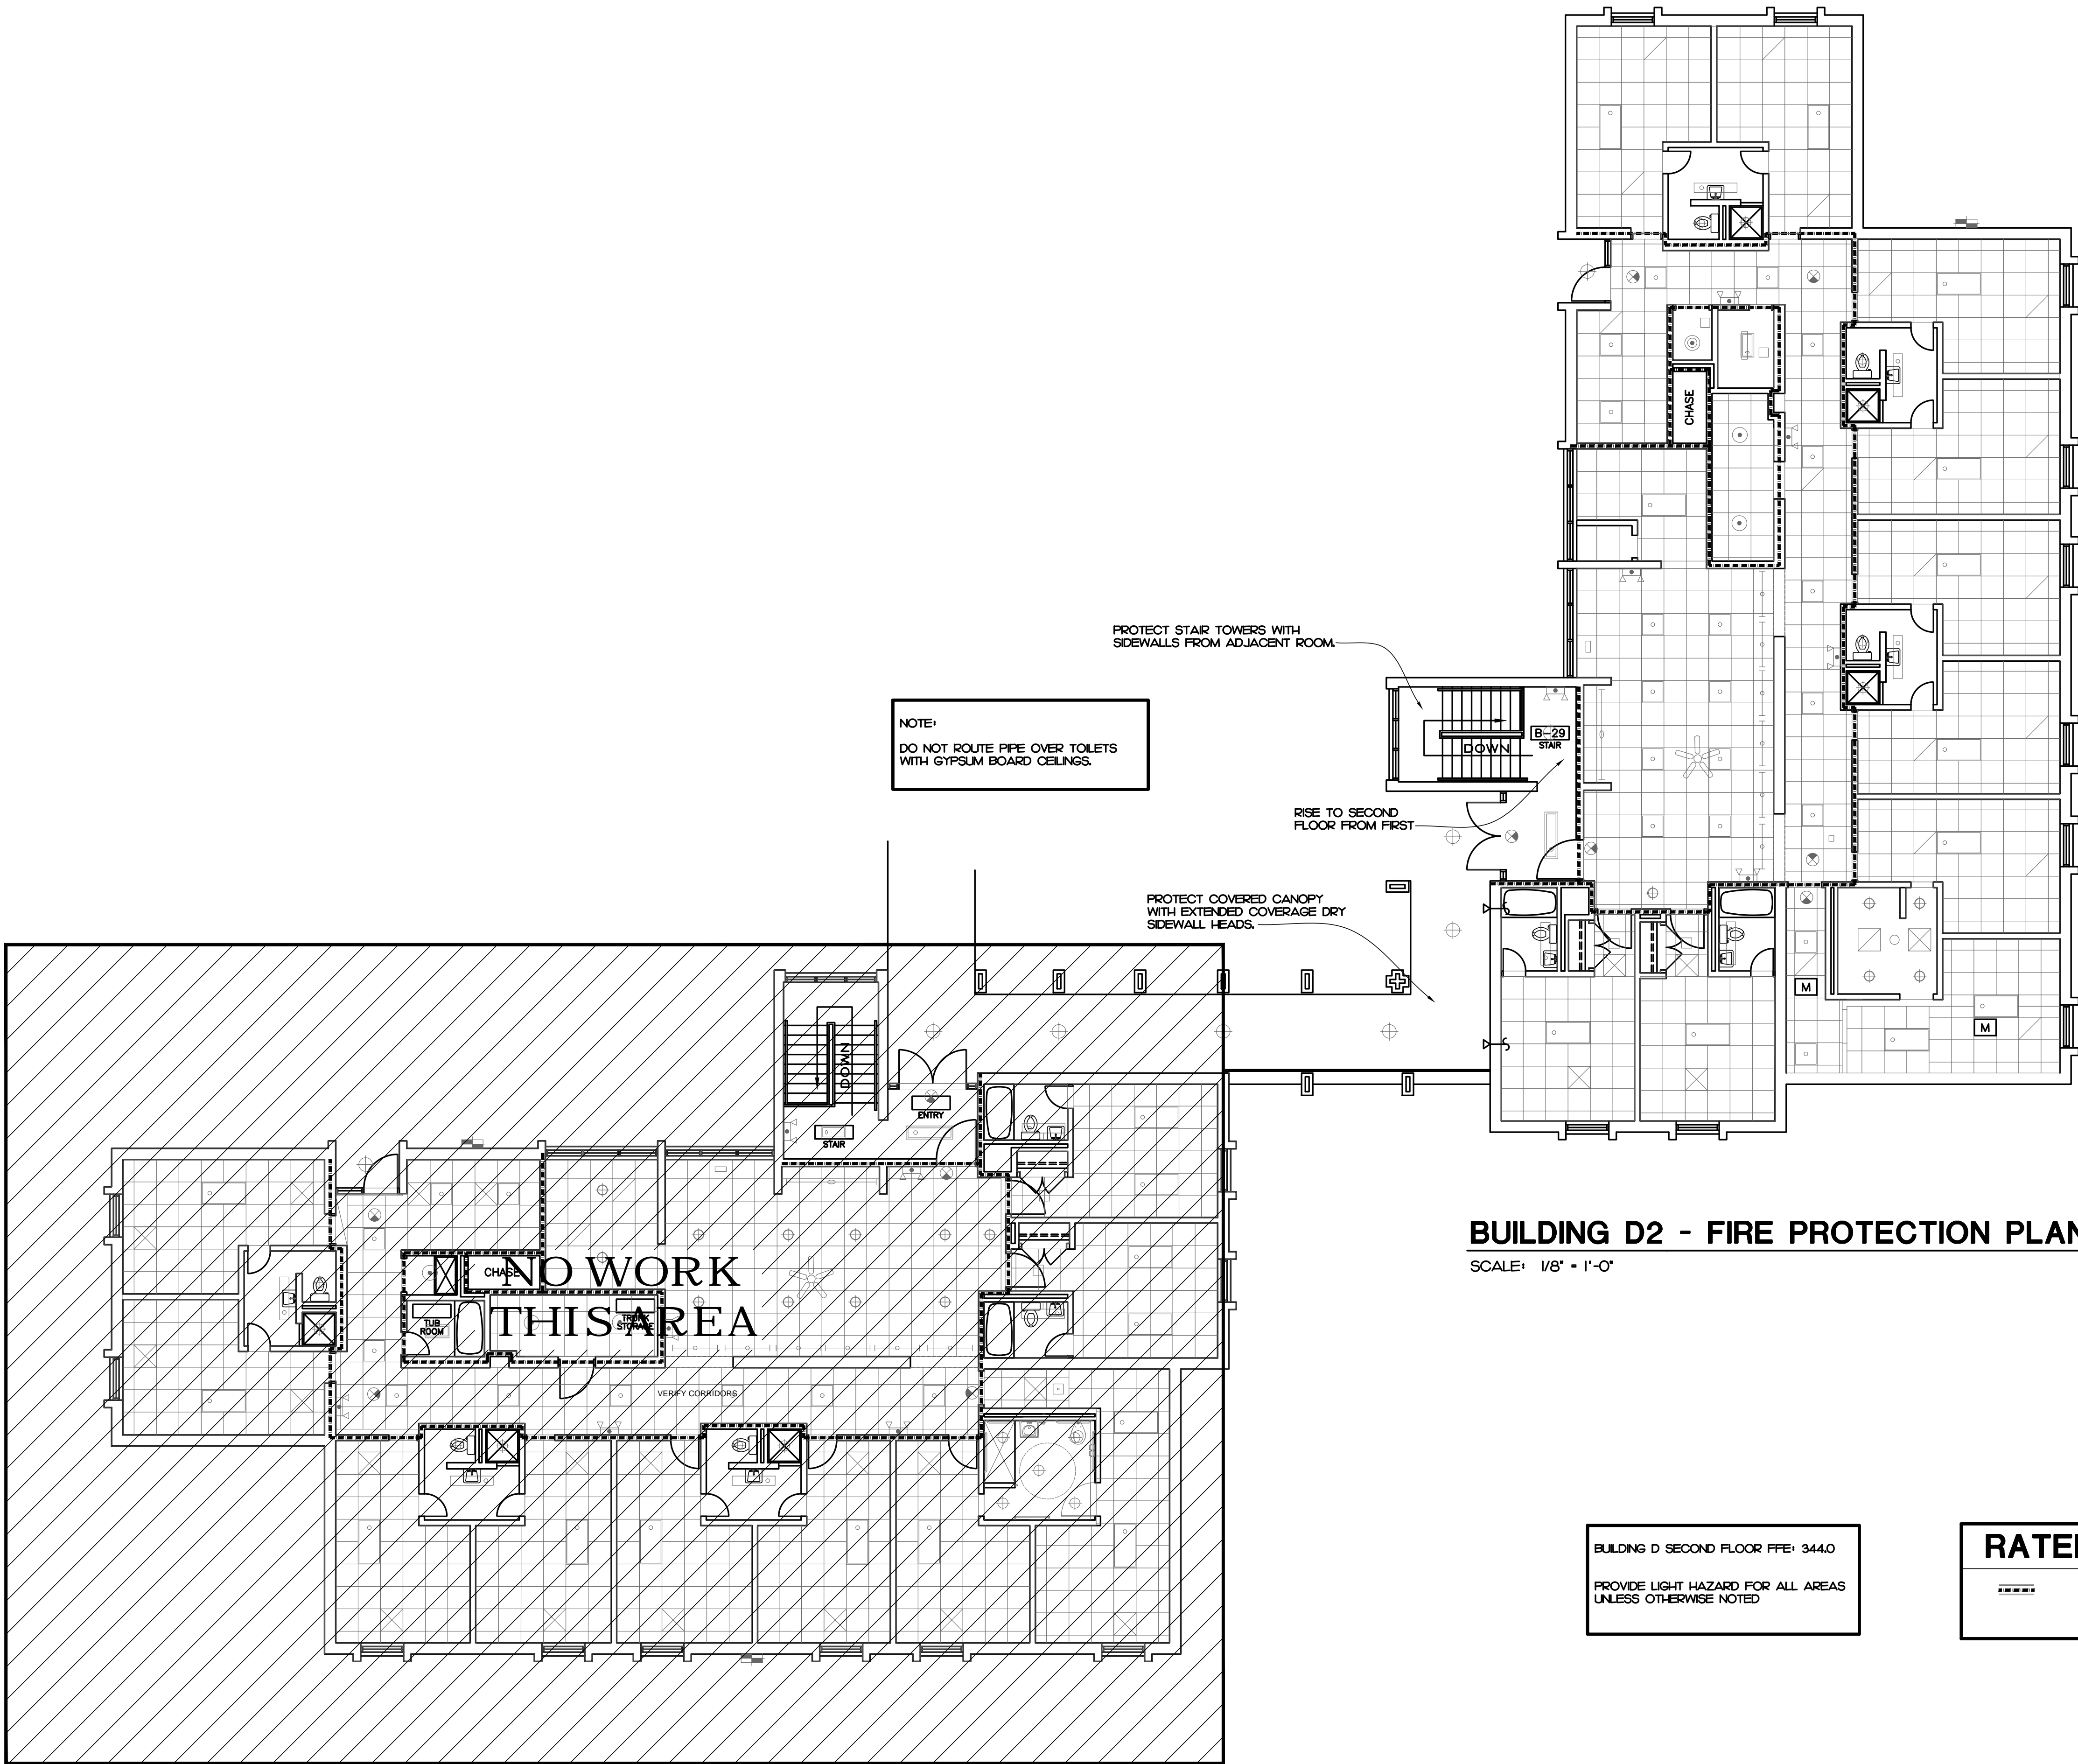

**BUILDING C2 - FIRE PROTECTION PLAN** 1  
SCALE: 1/8" = 1'-0"

**BUILDING D2 - FIRE PROTECTION PLAN** 2  
SCALE: 1/8" = 1'-0"

BUILDING D SECOND FLOOR FFE: 344.0  
PROVIDE LIGHT HAZARD FOR ALL AREAS  
UNLESS OTHERWISE NOTED

**RATED WALL LEGEND**  
===== 1 HOUR FIRE WALL

**IMEG**  
www.imegcorp.com  
3221 BLUE RIDGE ROAD, STE 113  
RALEIGH, NC 27612  
P: 919.971.1111  
IMEG RESERVES PROPRIETARY RIGHTS, INCLUDING COPYRIGHTS, TO THIS DRAWING AND THE DATA SHOWN THEREON. SAID DRAWING AND/OR DATA ARE THE EXCLUSIVE PROPERTY OF IMEG AND SHALL NOT BE USED OR REPRODUCED FOR ANY OTHER PROJECT WITHOUT THE EXPRESS WRITTEN APPROVAL AND PARTICIPATION OF IMEG.  
©2024 IMEG CONSULTANTS CORP.  
North Carolina Design Registration #F-1507  
REF. SCALE IN INCHES PROJECT # 24048

REVISIONS		FOR CONSTRUCTION	5/27/25

**ATLANTEC**  
ENGINEERS, P.A.  
IMEG  
3221 BLUE RIDGE ROAD, SUITE 113  
RALEIGH, NC 27612  
24048

Professional Engineer Seal  
Bradley W. Feltner  
No. 025036  
5/27/25

PREPARED FOR:  
NC DEPARTMENT  
OF INSTRUCTION  
SCO #  
24-27792-01A

GOVERNOR MOREHEAD SCHOOL  
SPRINKLER, ADA TOILET, LIGHTING  
UPGRADES FOR DORMS A, B, + D  
RALEIGH, NC

CONTENTS:  
FIRE PROTECTION  
BUILDING C/D -  
SECOND FLOOR

DATE:  
May 27, 2025

DESIGNER: JAD  
ENGINEER: BWF

SHEET NO.  
**FP-202**  
OF