


MECHANICAL KEY NOTES

- 1
- REMOVE EXISTING SUPPLY DIFFUSER AND SECURE IT FOR INSTALLATION IN NEW CEILING. RE-INSTALL IN NEW CEILING AS REQUIRED WITH RADIATION DAMPER AND FIRE BLANKET FOR NEW 1-HOUR RATED CEILING. FIELD VERIFY NECK SIZE.
- 2
- REMOVE EXISTING SIDEWALL SUPPLY GRILLE. PROVIDE FIRE DAMPER TO EXISTING SIDEWALL SUPPLY GRILLE AND RE-INSTALL AS REQUIRED. FIELD VERIFY SIZE AND EXISTING CONDITIONS BEFORE WORK.
- 3
- REMOVE EXISTING RETURN GRILLE AND SECURE IT FOR INSTALLATION IN NEW CEILING. RE-INSTALL IN NEW CEILING AS REQUIRED WITH RADIATION DAMPER AND FIRE BLANKET FOR NEW 1-HOUR RATED CEILING. FIELD VERIFY NECK SIZE.


NOTES:
REMOVE EXISTING SUPPLY DIFFUSERS, RETURN GRILLES, AND EXHAUST FANS IN EXISTING CEILING AND SECURE IT FOR INSTALLATION IN NEW CEILING UNLESS OTHERWISE NOTED. RE-INSTALL IN NEW CEILING AS REQUIRED.

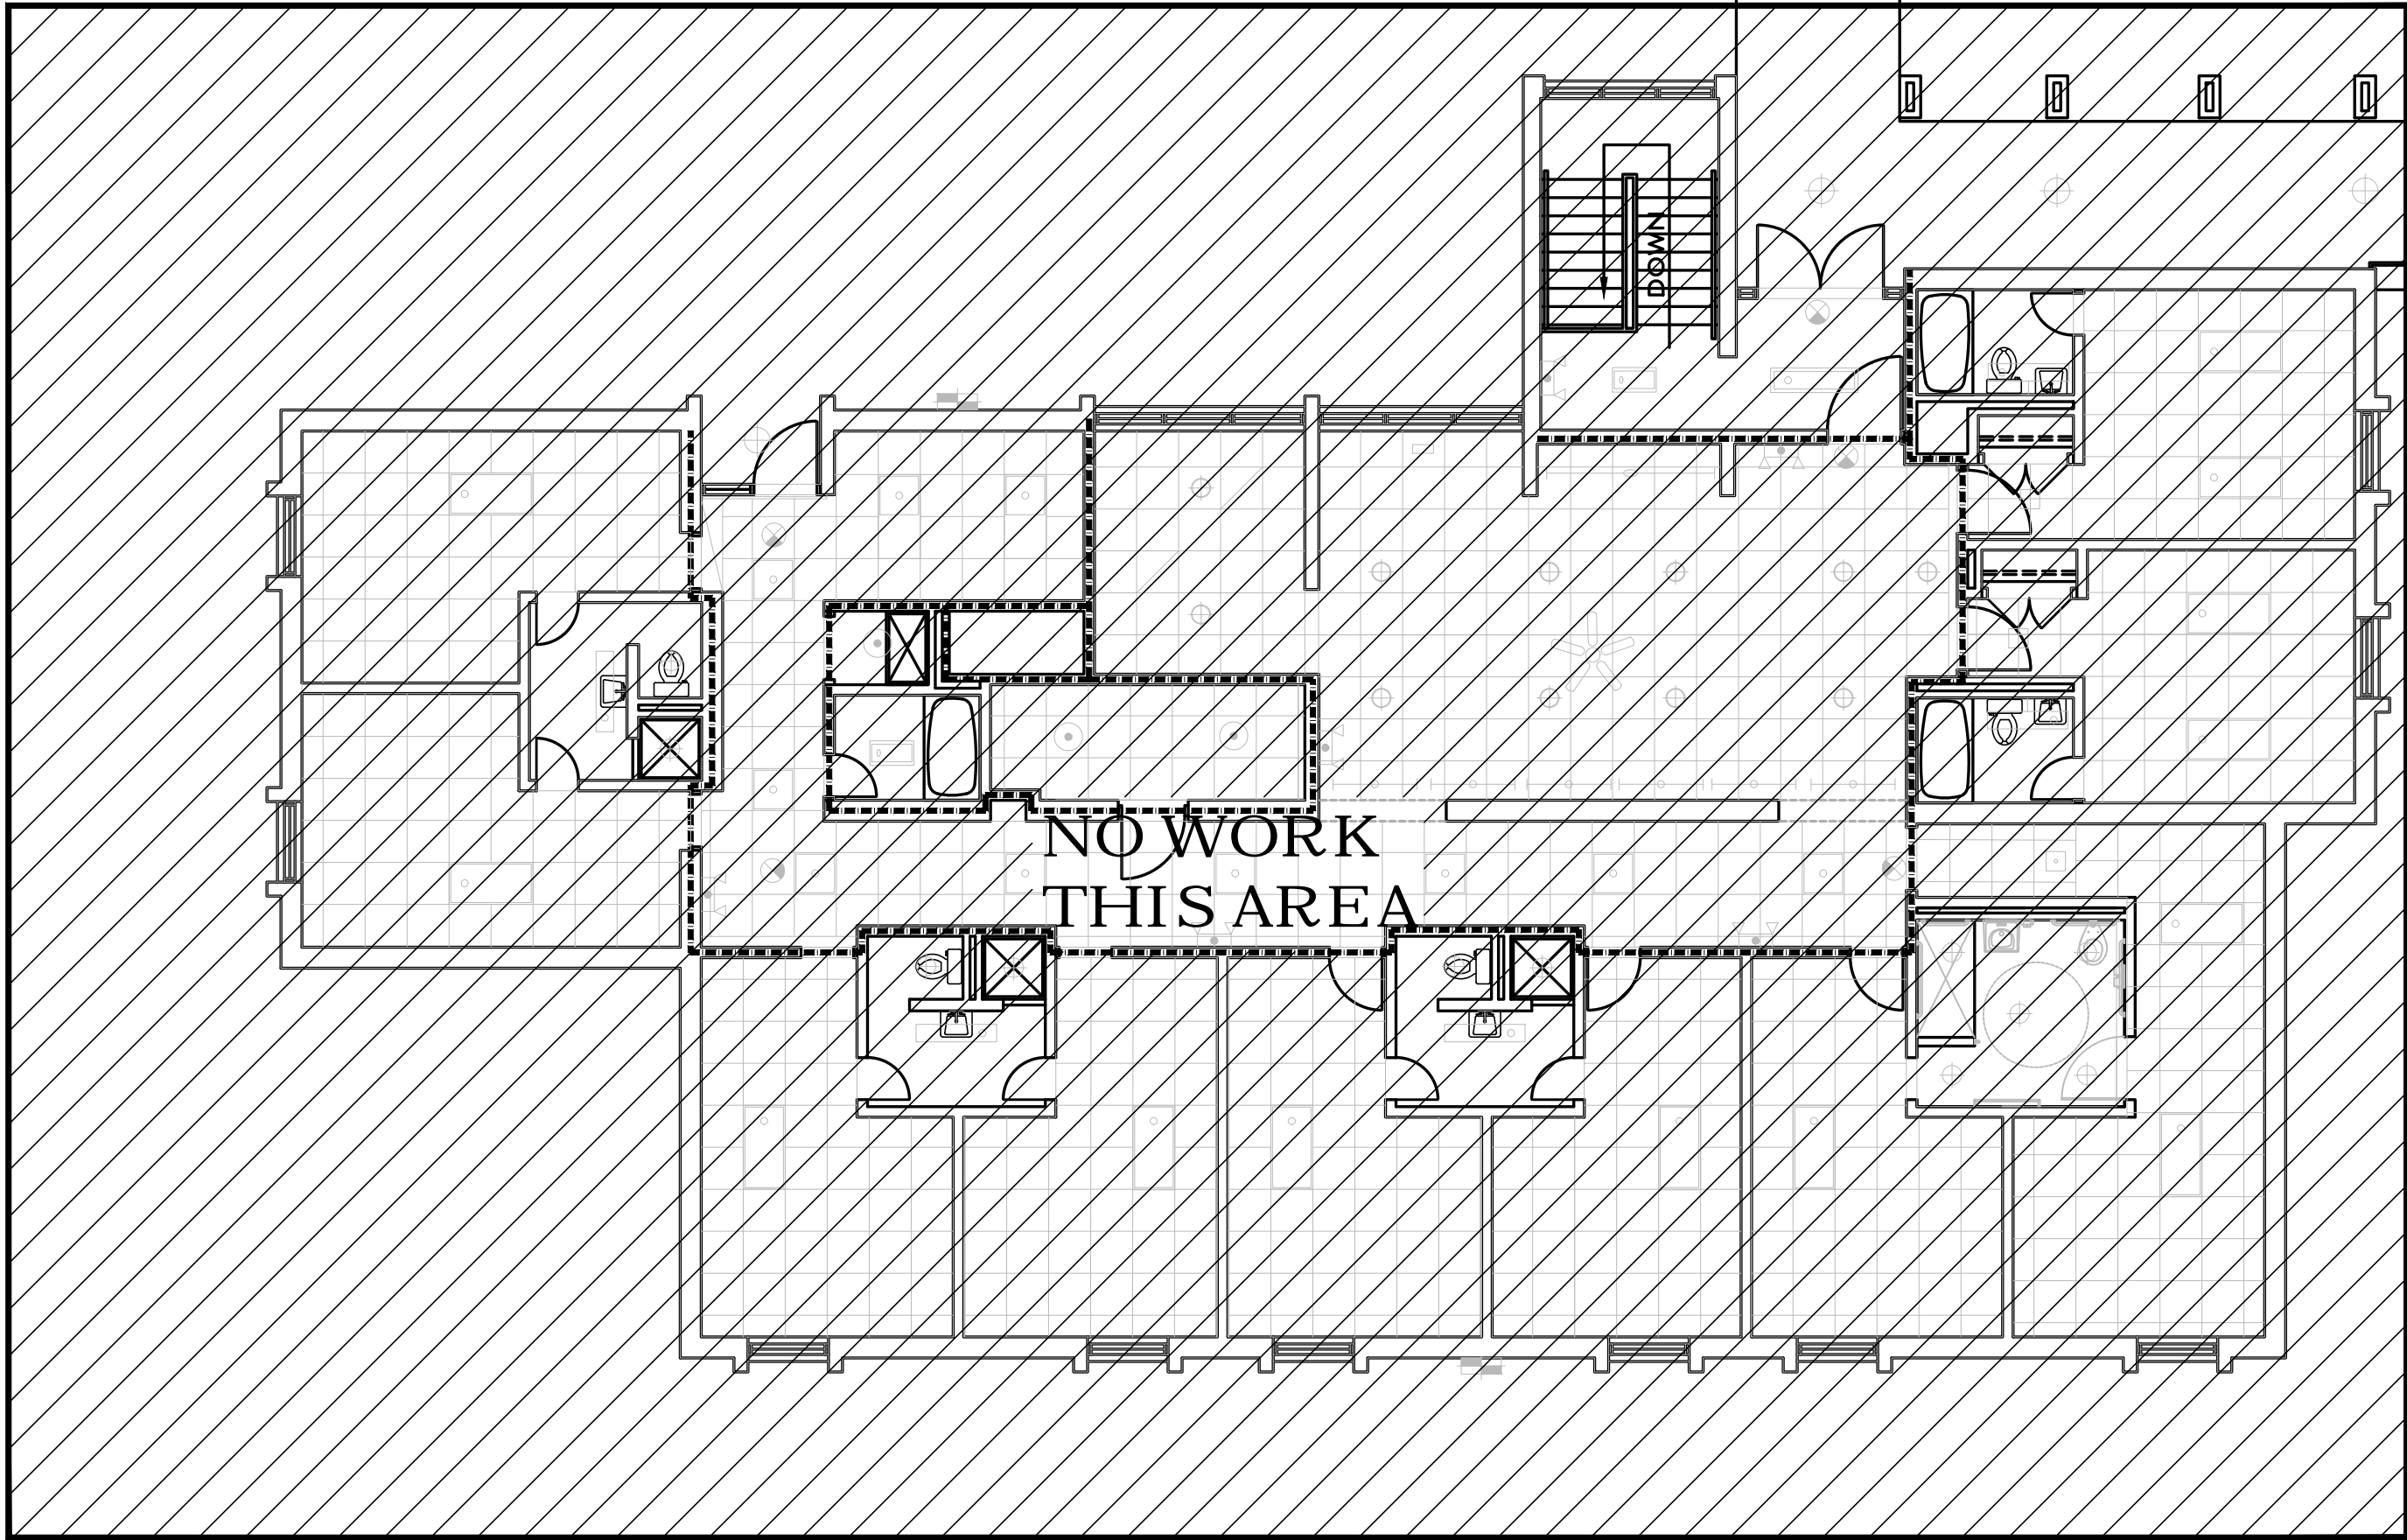

BUILDING C2 - MECHANICAL PLAN

SCALE: 1/8" = 1'-0"

1

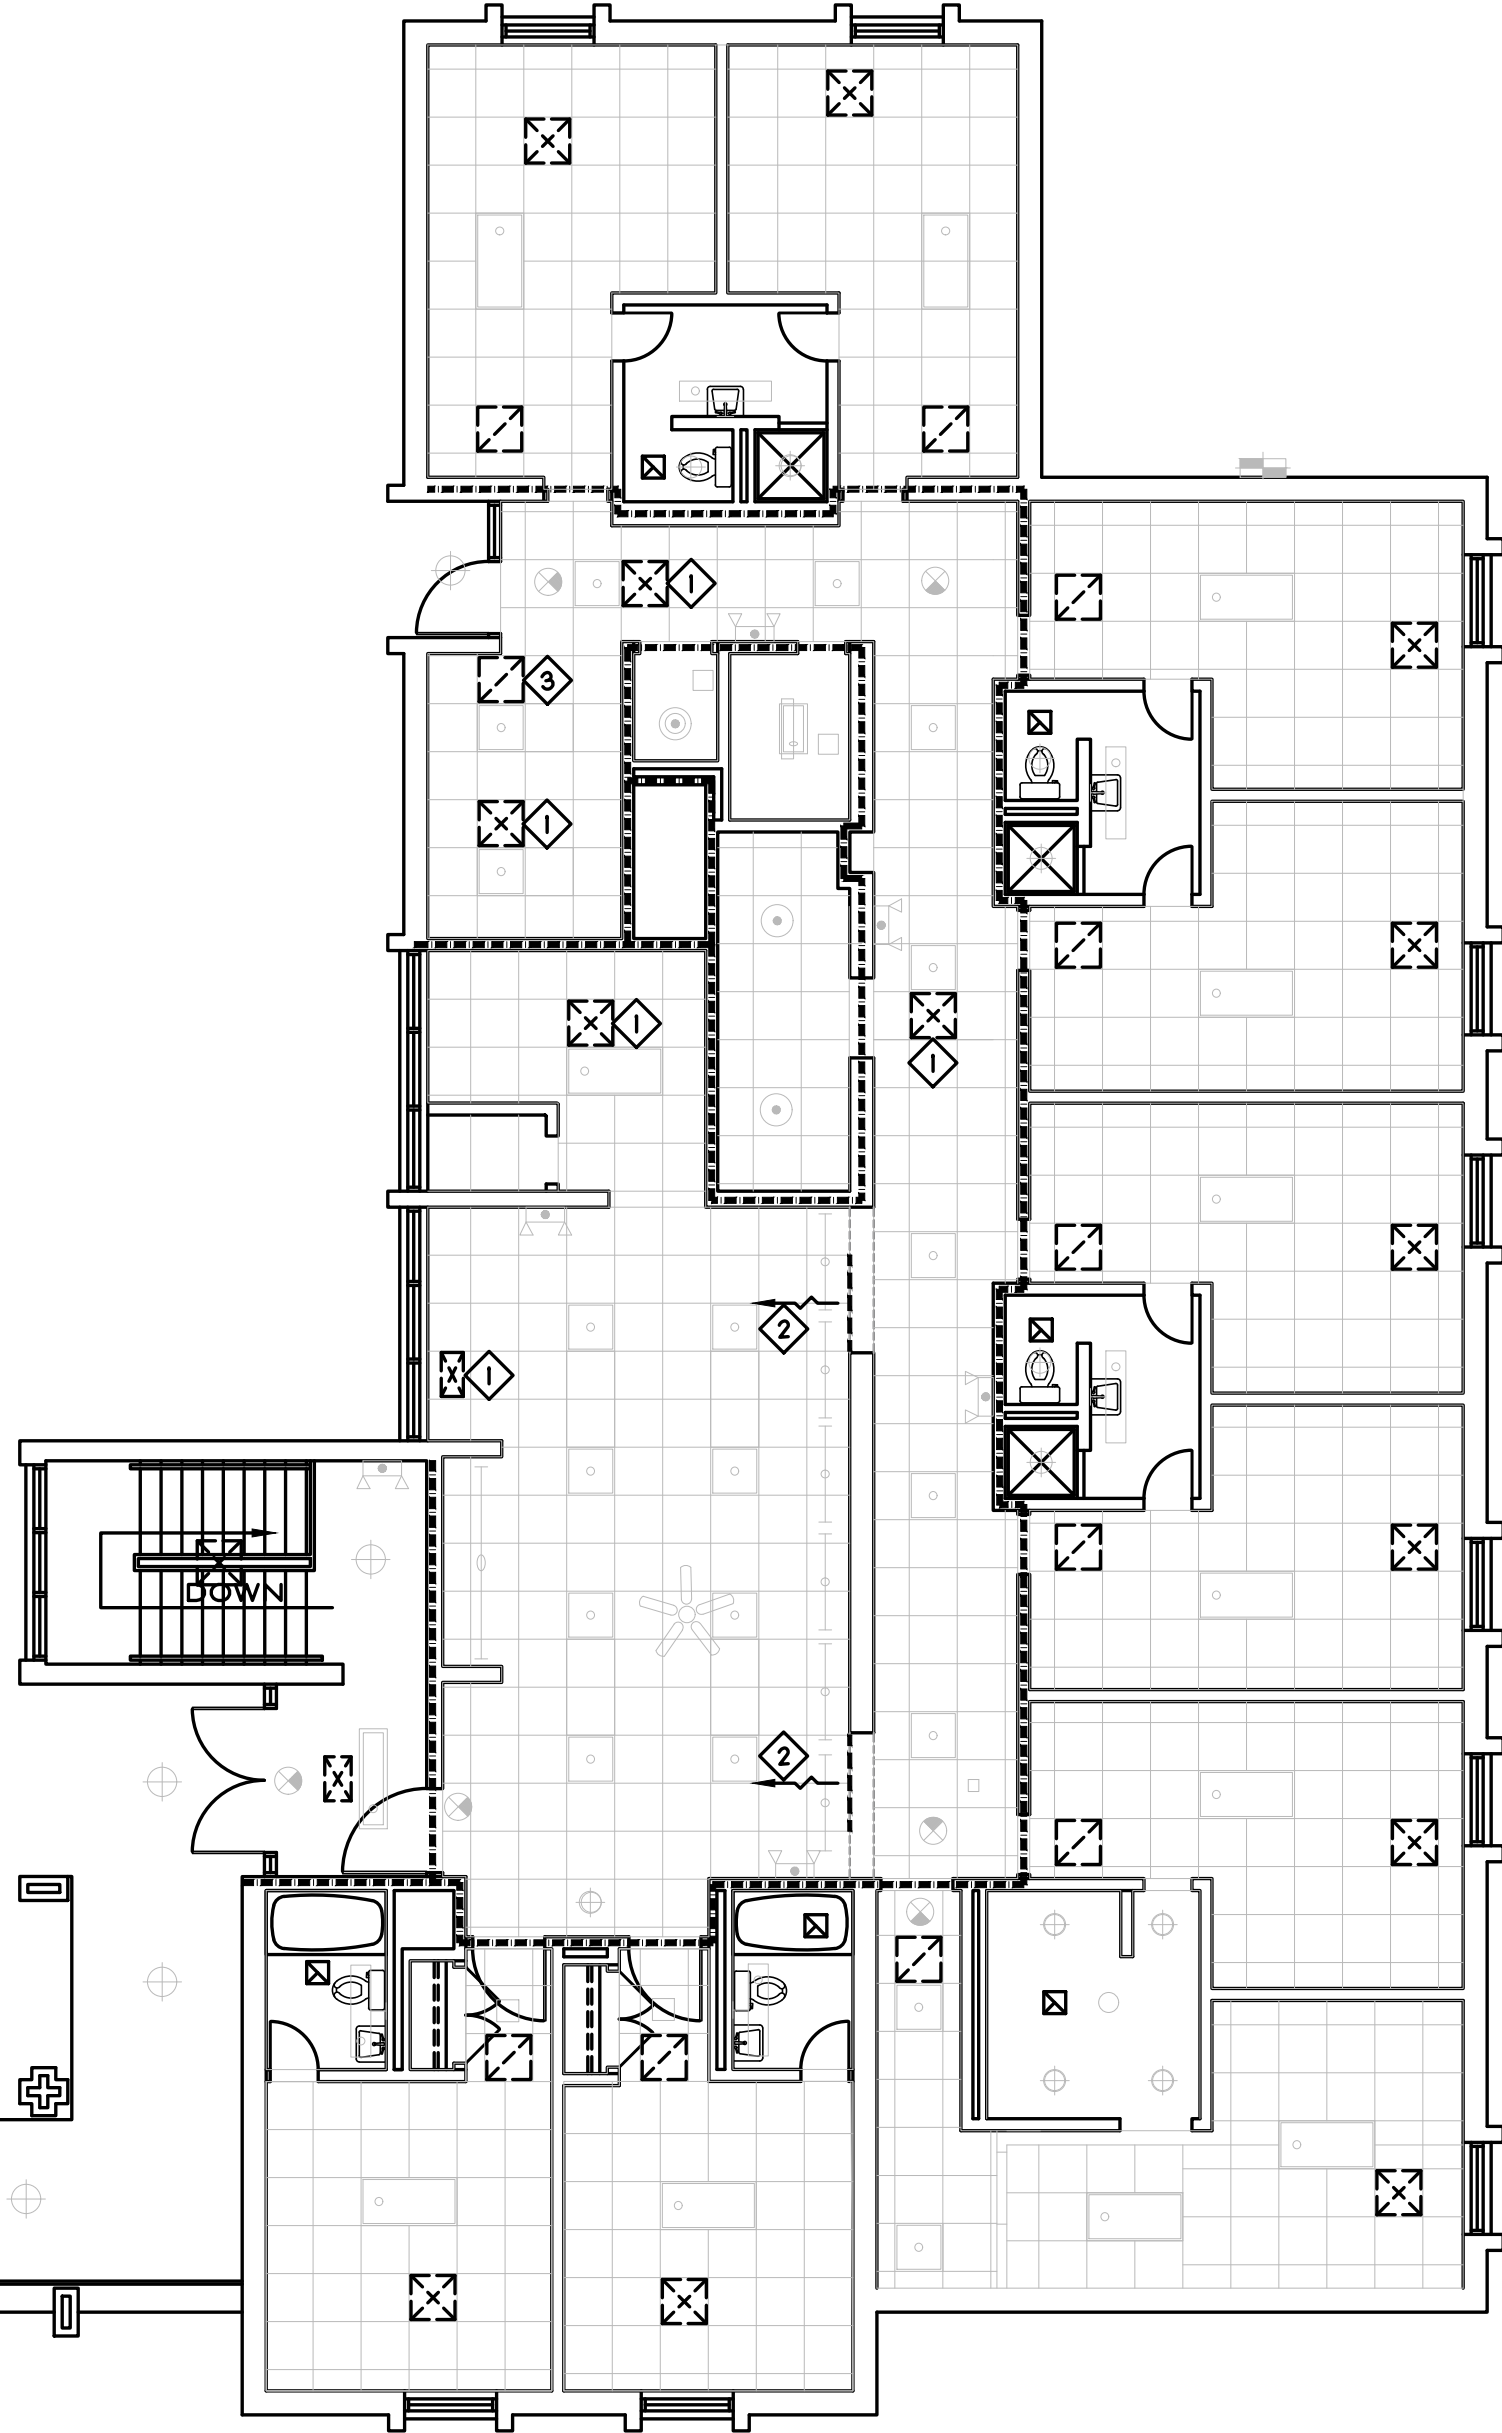


BUILDING D2 - MECHANICAL PLAN

SCALE: 1/8" = 1'-0"

2

 
RATED WALL LEGEND

1 HOUR FIRE WALL




3321 BLUE RIDGE ROAD, STE 113
RALEIGH, NC 27612
P: 919.971.1111
www.imegcorp.com

IMEG RESERVES PROPRIETARY RIGHTS, INCLUDING COPYRIGHTS, TO THIS DRAWING AND THE DATA SHOWN THEREON. SAID DRAWING AND/OR DATA ARE THE EXCLUSIVE PROPERTY OF IMEG AND SHALL NOT BE USED OR REPRODUCED FOR ANY OTHER PROJECT WITHOUT THE EXPRESS WRITTEN APPROVAL AND PARTICIPATION OF IMEG.
©2024 IMEG CONSULTANTS CORP.
North Carolina Design Registration #F-1507



REF. SCALE IN INCHES PROJECT # 24048

REVISIONS	FOR	CONSTRUCTION	5/27/25		

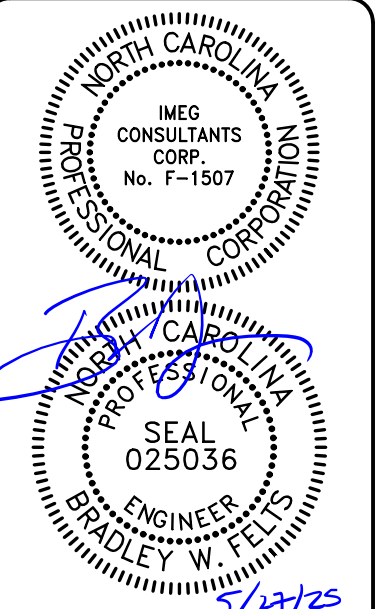

ATLANTEC

ENGINEERS, P.A.

IMEG

3321 BLUE RIDGE ROAD, SUITE 113
RALEIGH, NC 27612
24048

PREPARED FOR:
NC DEPARTMENT
OF INSTRUCTION
SCO #
24-27792-01A

GOVERNOR MOREHEAD SCHOOL
SPRINKLER, ADA TOILET, LIGHTING
UPGRADES FOR DORMS A, B, + D
RALEIGH, NC

CONTENTS:
MECHANICAL
PLAN - BUILDING
C/D SECOND FLOOR

DATE:
May 27, 2025

DESIGNER: JAD
ENGINEER: BWF

SHEET NO.
M-104
OF --